[illegible]

COMPUTER DRAWING
MS_FA101.dwg


DATE: JAN. 2023	
DRAWN BY:	CHECKED BY:
CH, DH, TC, JC	MRH

SHEET


Fire Alarm

FA1.1


OF - SHEETS

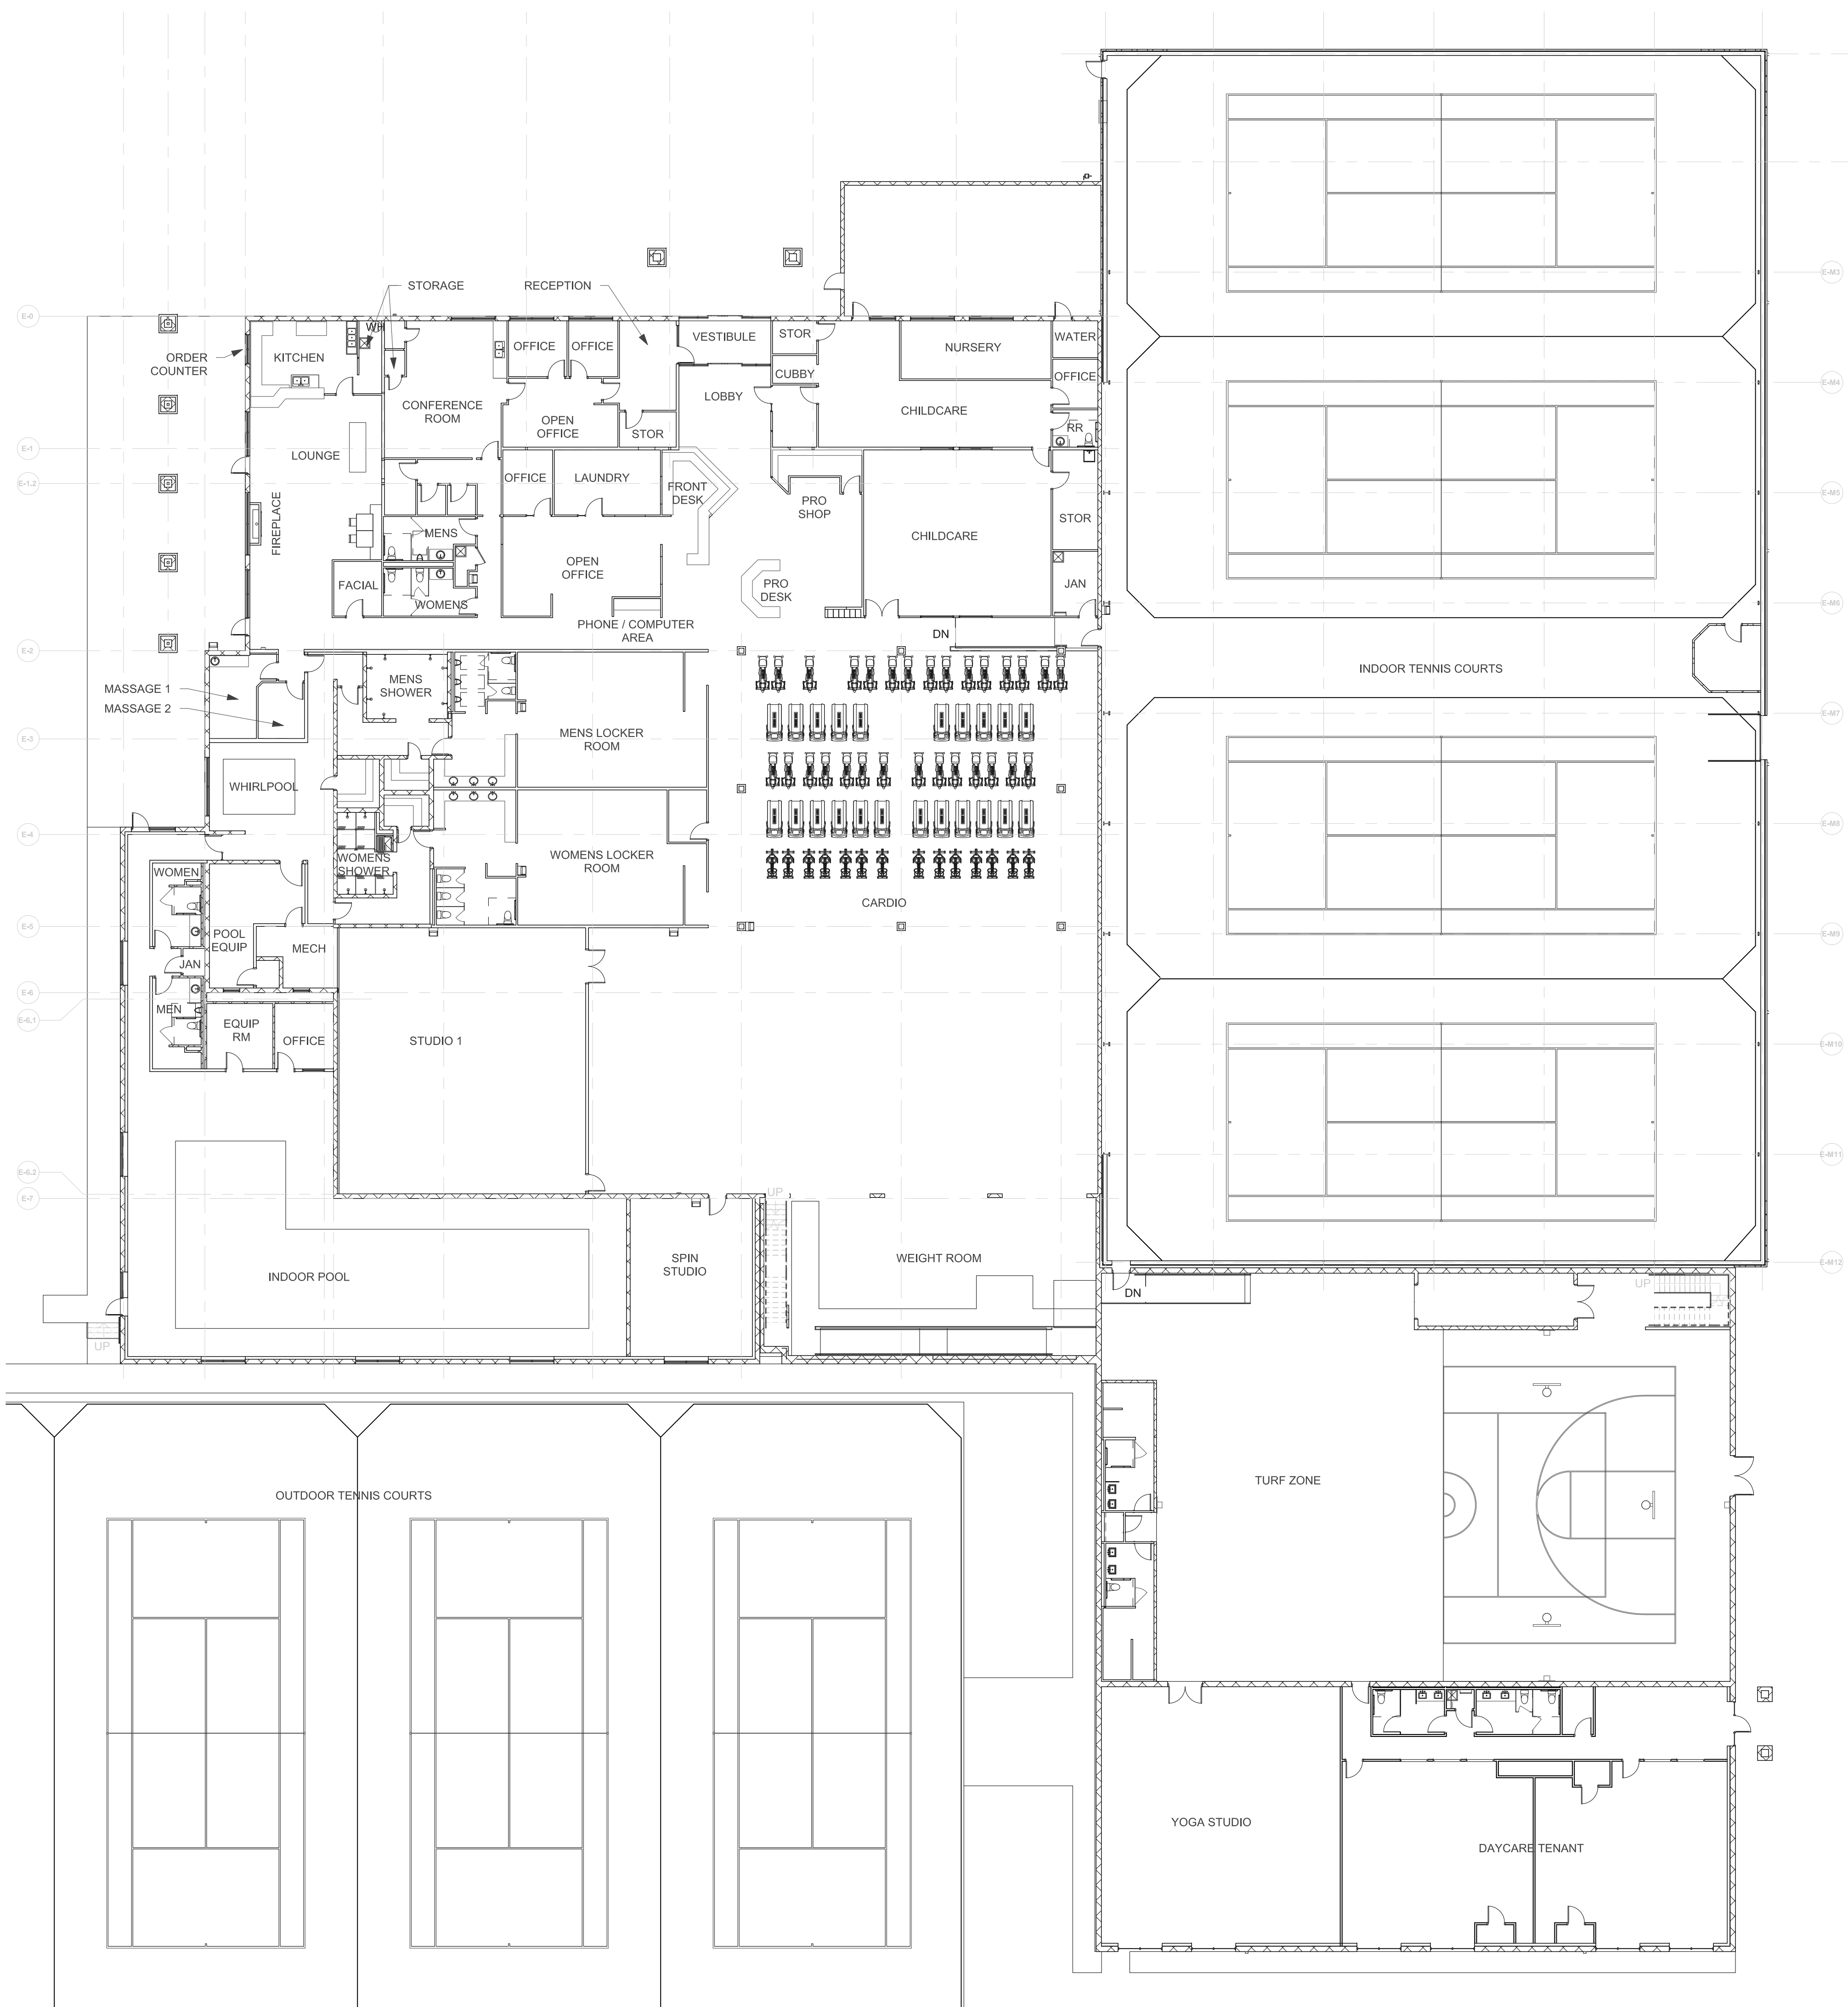


A EXISTING OVERALL
FIRST FLOOR PLAN
SCALE: 1/16" = 1'-0"

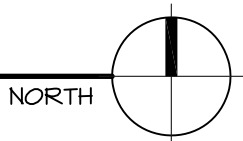

VICINITY PLAN

 




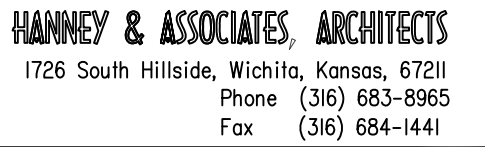
[illegible]

COMPUTER DRAWING
MS_FA102.dwg


DATE: JAN. 2023	
DRAWN BY:	CHECKED BY:
CH, DH, TC, JC	MRH


Fire Alarm

 FA1.2

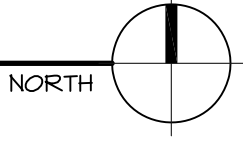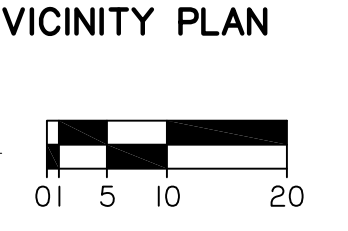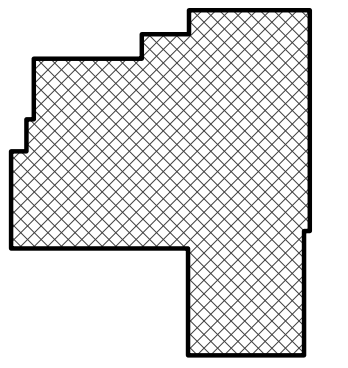

A EXISTING OVERALL
FIRST FLOOR PLAN
SCALE: 1/16" = 1'-0"

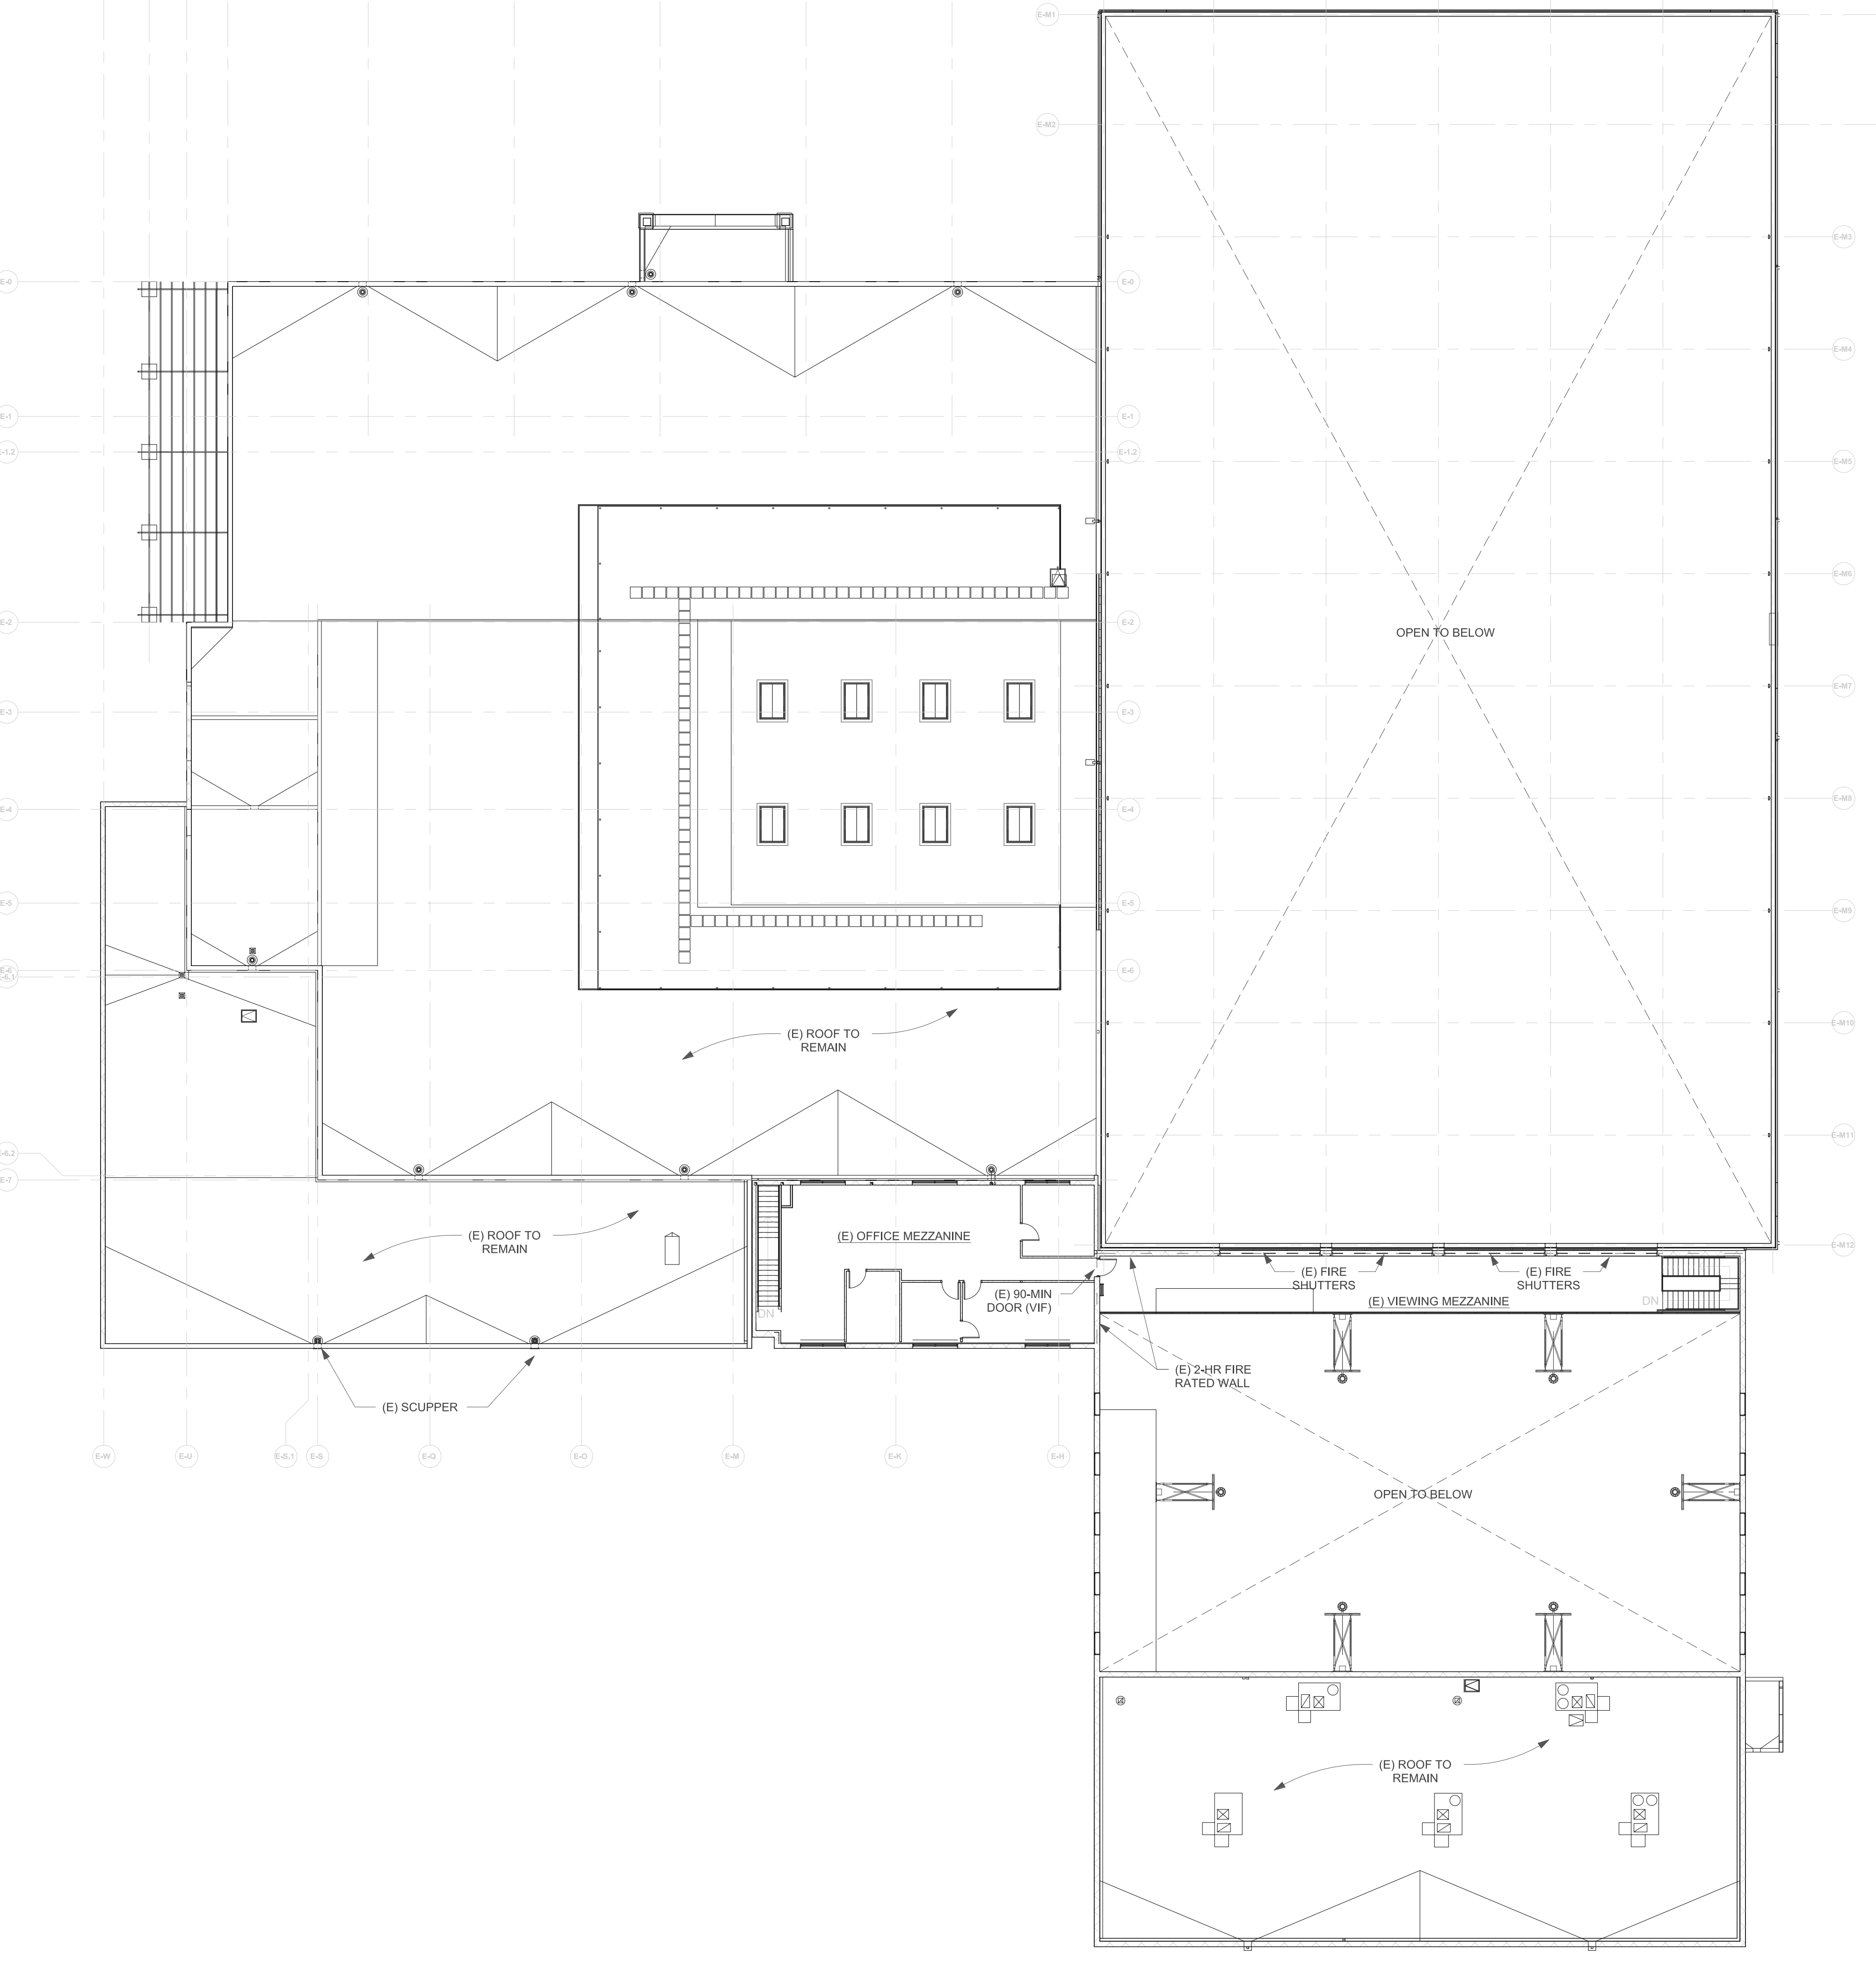

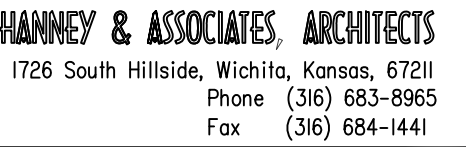

2022
GENESIS HEALTH CLUBS
MIRAMONT-SOUTH
901 Oakridge Drive - Fort Collins, Colorado 80525



DRAWINGS		ISSUED	
NO.	DATE	ITEM	ISSUED
I	I/17/23	FIRE ALARM BID	


COMPUTER DRAWING
MS_A101.dwg


DATE: JAN. 2023	
DRAWN BY:	CHECKED BY:
CH, DH, TC, JC	MRH

SHEET

A1.1

OF - SHEETS

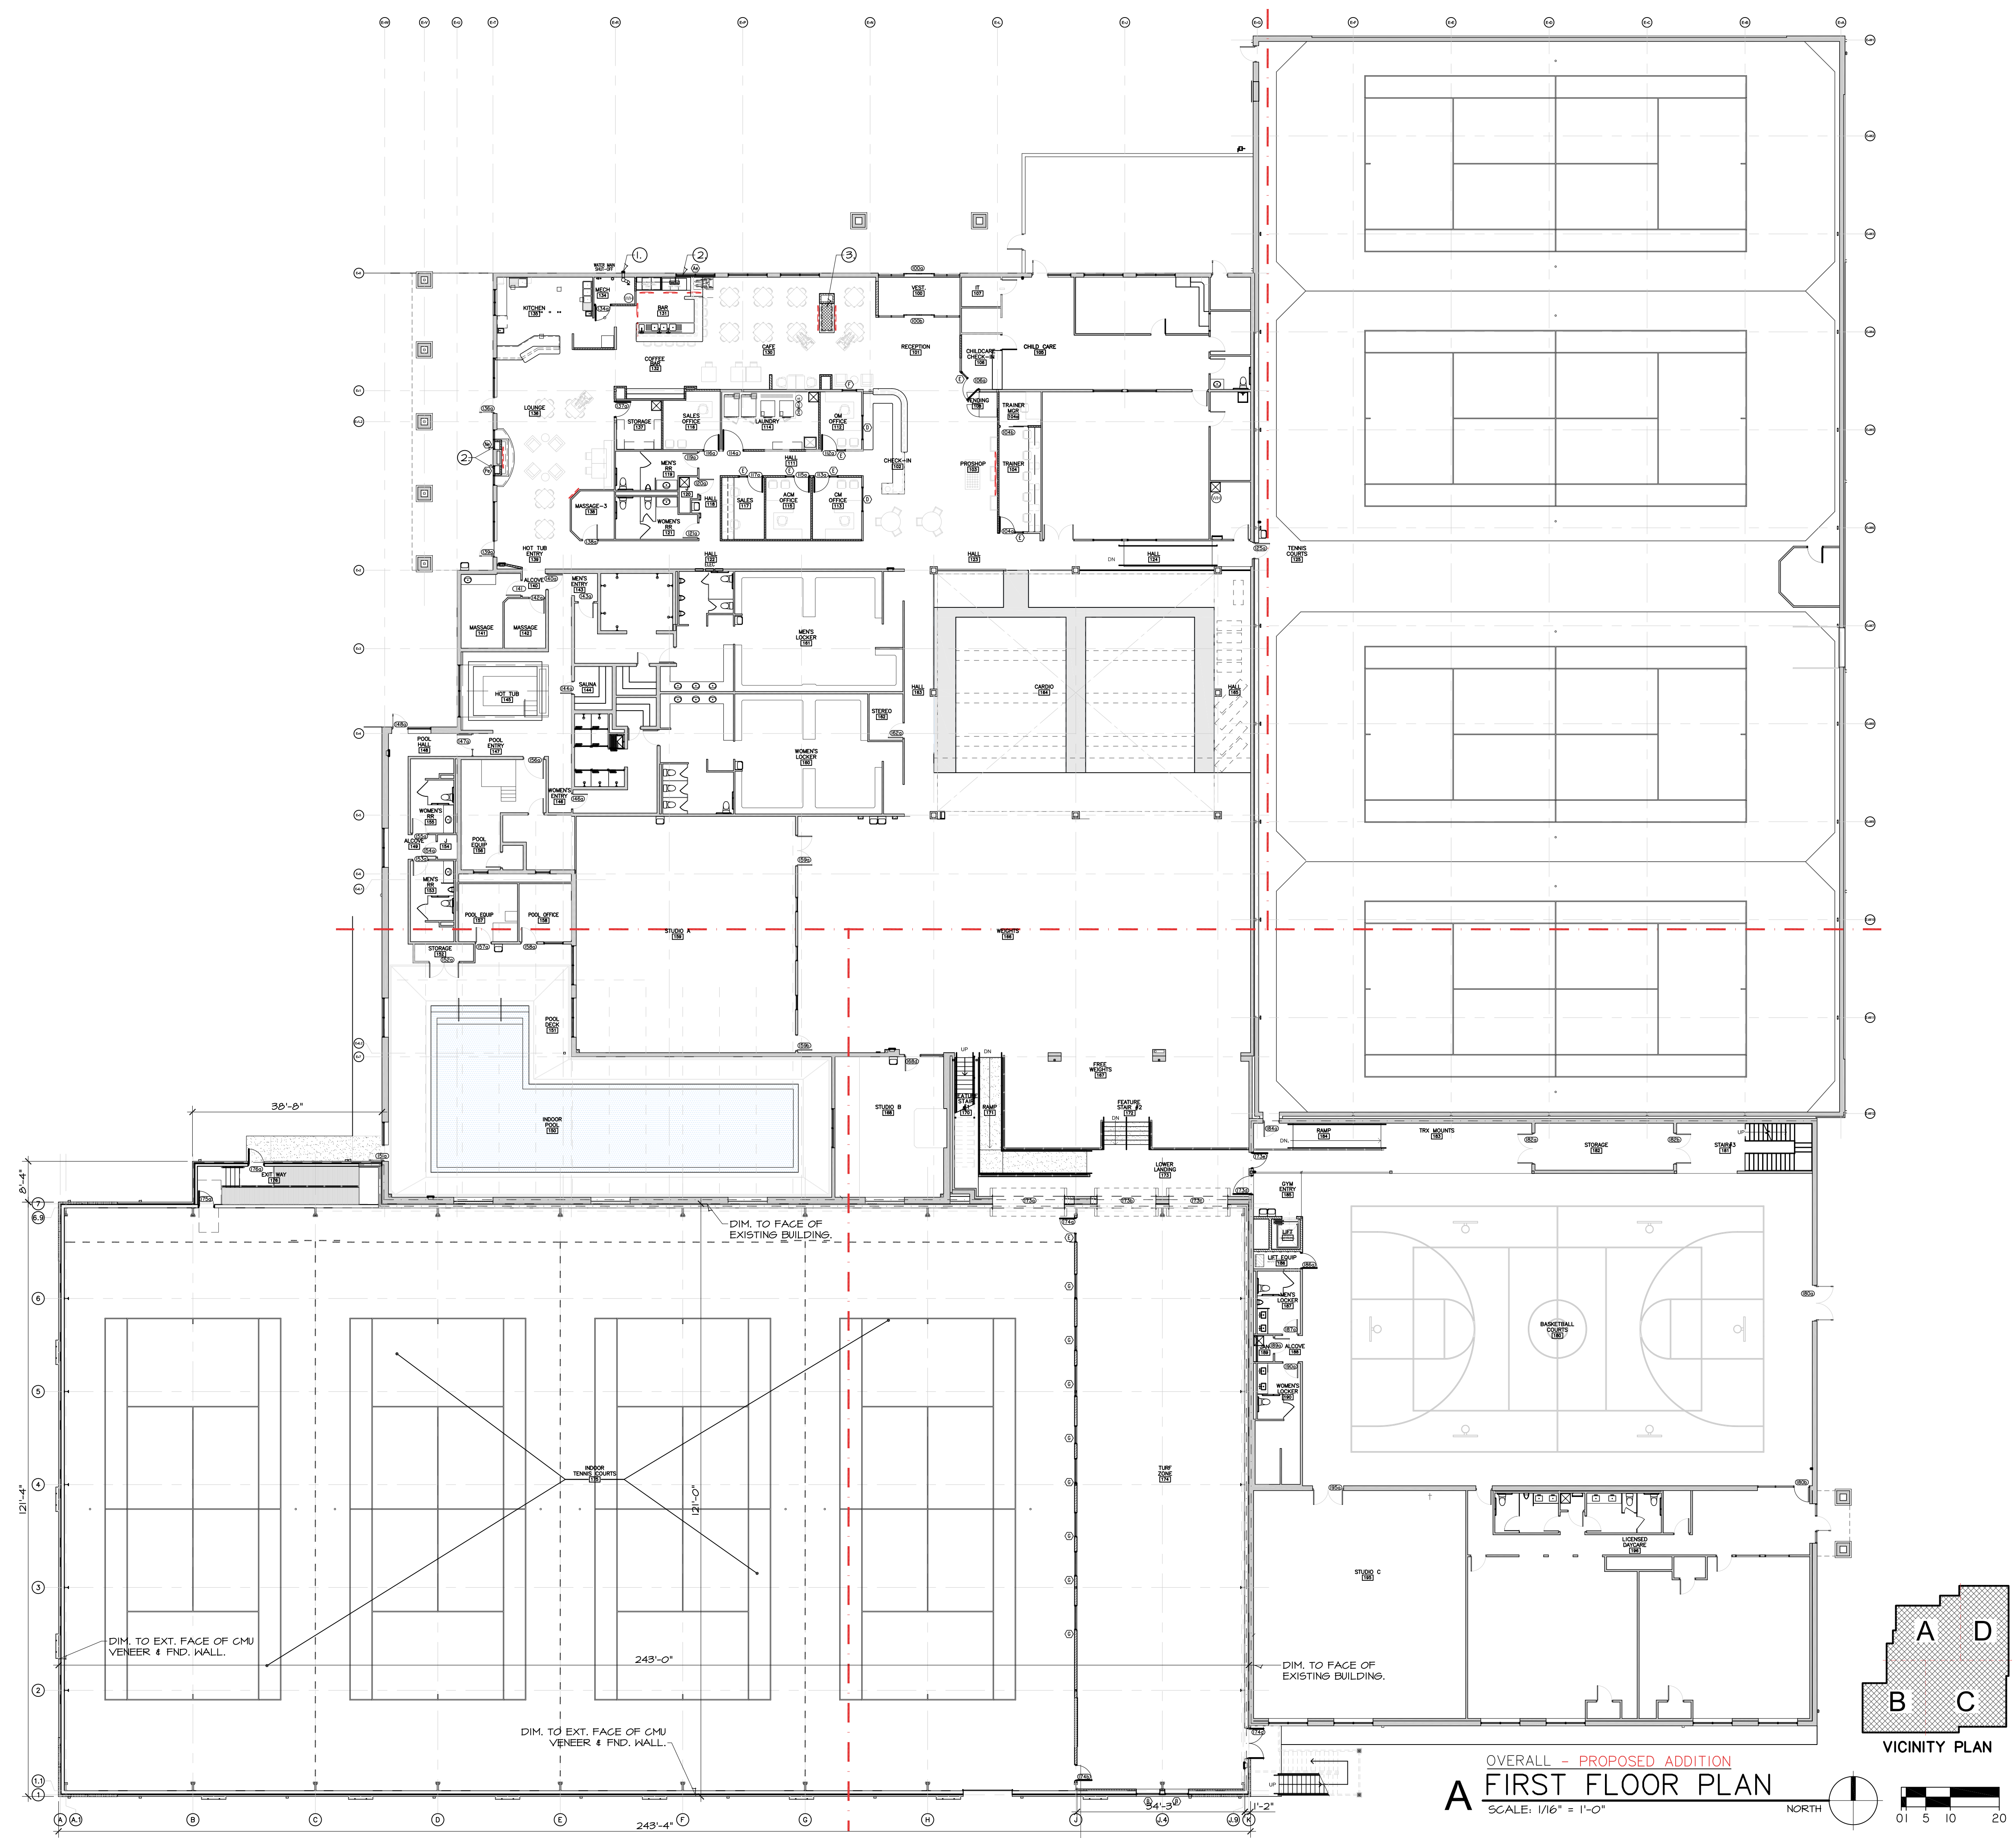

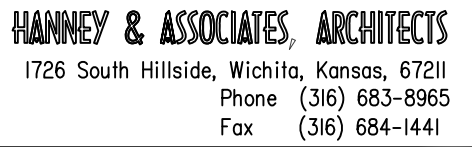

DRAWINGS		ISSUED	
NO.	DATE	ITEM	ISSUED
I	I/17/23	FIRE ALARM BID	

COMPUTER DRAWING
MS_A101.dwg

DATE: JAN. 2023	
DRAWN BY:	CHECKED BY:
CH, DH, TC, JC	MRH

SHEET

A1.2

OF - SHEETS

